

SITE SYMBOLS	
	= POWER POLE
	= GUY WIRE
	= WATER VALVE
	= FIRE HYDRANT
	= SIGN
	= SANITARY SEWER MANHOLE
	= SANITARY SEWER CLEANOUT
	= STORM SEWER MANHOLE
	= PROPERTY LINE
	= BUILDING SETBACK LINE
	= EASEMENT LINE
	= ELECTRIC LINE
	= WATER LINE
	= SEWER LINE
	= STORM DRAIN LINE
	= CONCRETE
	= GRASS AS PER CITY OF WACO PLANTING LIST
	= GROUNDCOVER AS PER CITY OF WACO PLANTING LIST
	= NORTH ARROW



STERLING ARCHITECTS, LLC
2416 COLUMBUS AVENUE
WACO, TEXAS 76701
P: 254.756.2311
F: 254.756.2577
SterlingThompson_architect@yahoo.com

THESE DOCUMENTS AND DESIGNS ARE THE PROPERTY OF THE ARCHITECT AND NO PART SHALL BE COPIED OR DUPLICATED WITHOUT HIS WRITTEN PERMISSION. UNAUTHORIZED DUPLICATION OF THESE PLANS IN WHOLE OR IN PART IS STRICTLY PROHIBITED. ALL COPY RIGHT LAWS ARE APPLICABLE.
© COPYRIGHT 2018



00/00/00

SHOPPING CENTER AT I-35 & 18TH STREET WACO, TX

NOT FOR CONSTRUCTION

NOT FOR PERMITTING


PROJECT #:	2017-11-10
DRAWN:	SBK
CHECKED:	SWT
DATE:	00/00/00
REVISIONS:	
0	00/00/00

COPYRIGHT © 2018
ALL RIGHTS RESERVED

SITE PLAN

A1.0



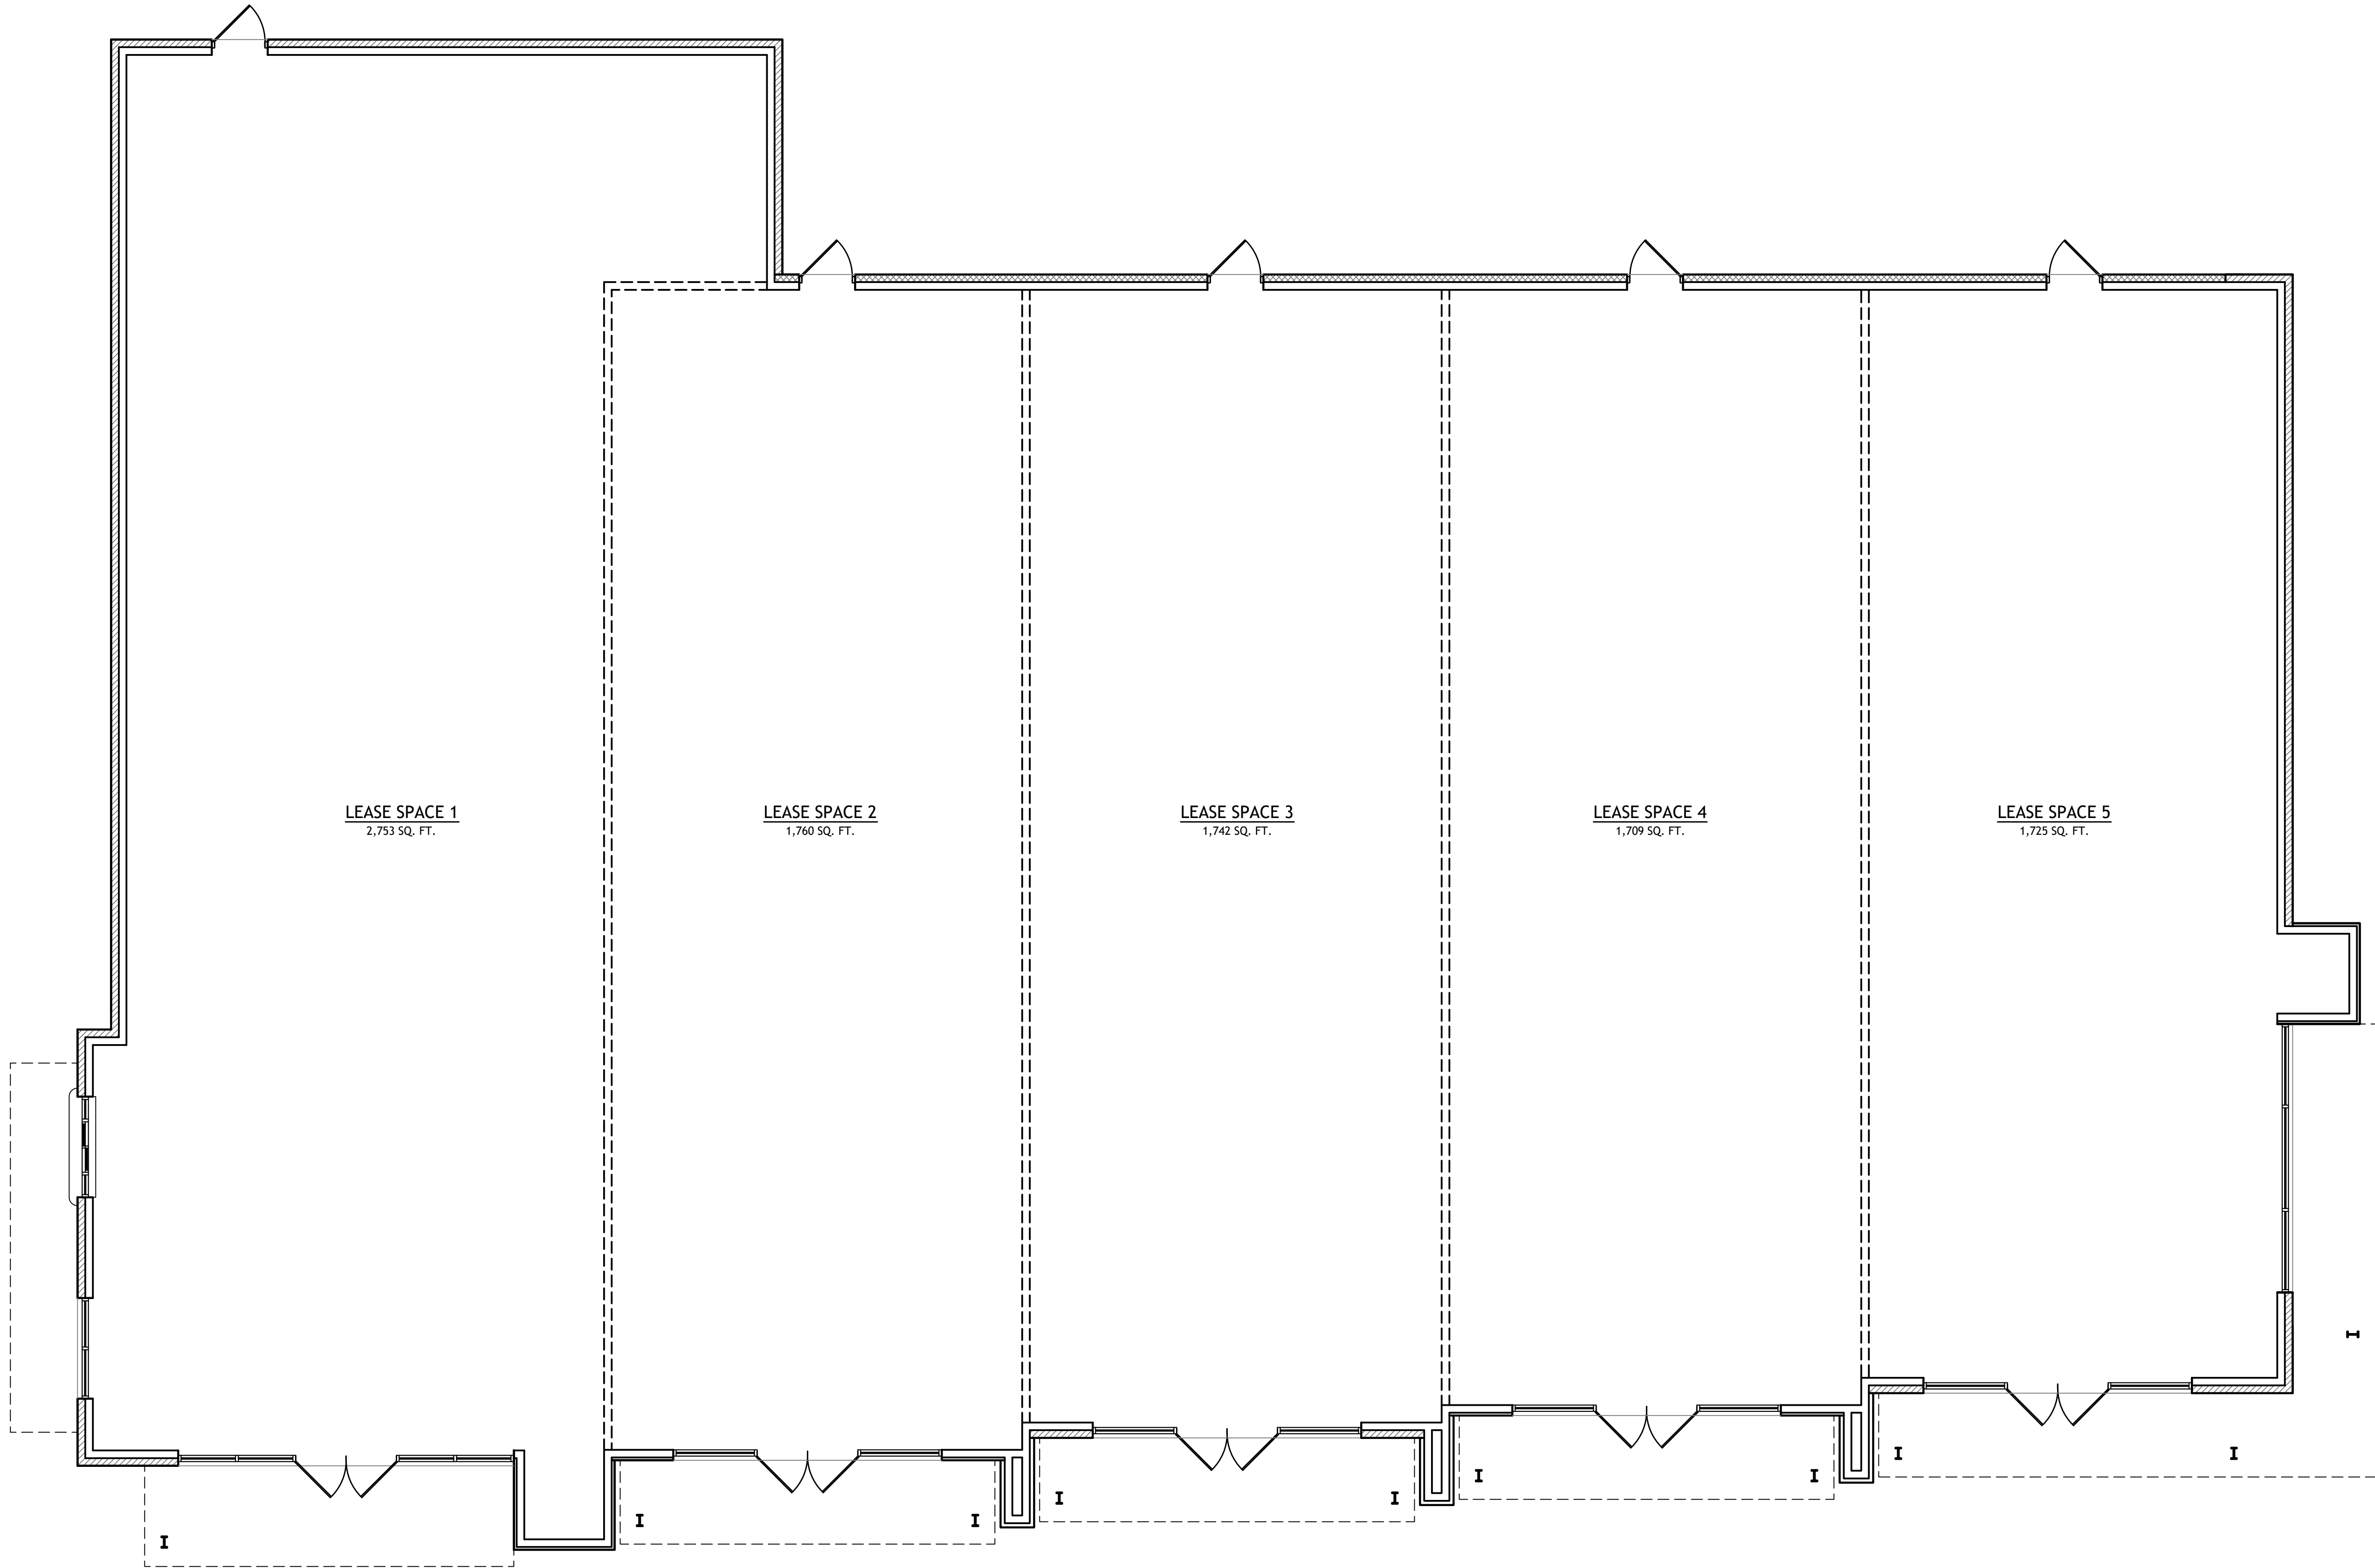

1 FLOOR PLAN
3/16" = 1'-0"
9,689 SQ. FT. TOTAL



STERLING ARCHITECTS, LLC
2416 COLUMBUS AVENUE
WACO, TEXAS 76701
P: 254.756.2311
F: 254.756.2577
SterlingThompson_architect@yahoo.com

THESE DOCUMENTS AND DESIGNS ARE THE PROPERTY OF THE ARCHITECT AND NO PART SHALL BE COPIED OR DUPLICATED WITHOUT HIS WRITTEN PERMISSION. UNAUTHORIZED DUPLICATION OF THESE PLANS IN WHOLE OR IN PART IS STRICTLY PROHIBITED. ALL COPY RIGHT LAWS ARE APPLICABLE.
© COPYRIGHT 2018



00/00/00

SHOPPING CENTER
AT
I-35 & 18TH STREET
WACO, TX

NOT FOR CONSTRUCTION
NOT FOR PERMITTING

PROJECT #:	2017-11-10
DRAWN:	SBK
CHECKED:	SWT
DATE:	00/00/00
REVISIONS:	
0	00/00/00

COPYRIGHT © 2018
ALL RIGHTS RESERVED

FLOOR PLAN

A1.1